
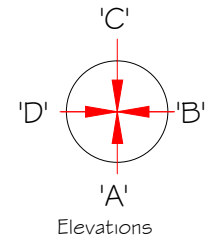


Todd Devine Homes

Builders of quality dependent relatives units,
transportable homes and tourist accommodation.

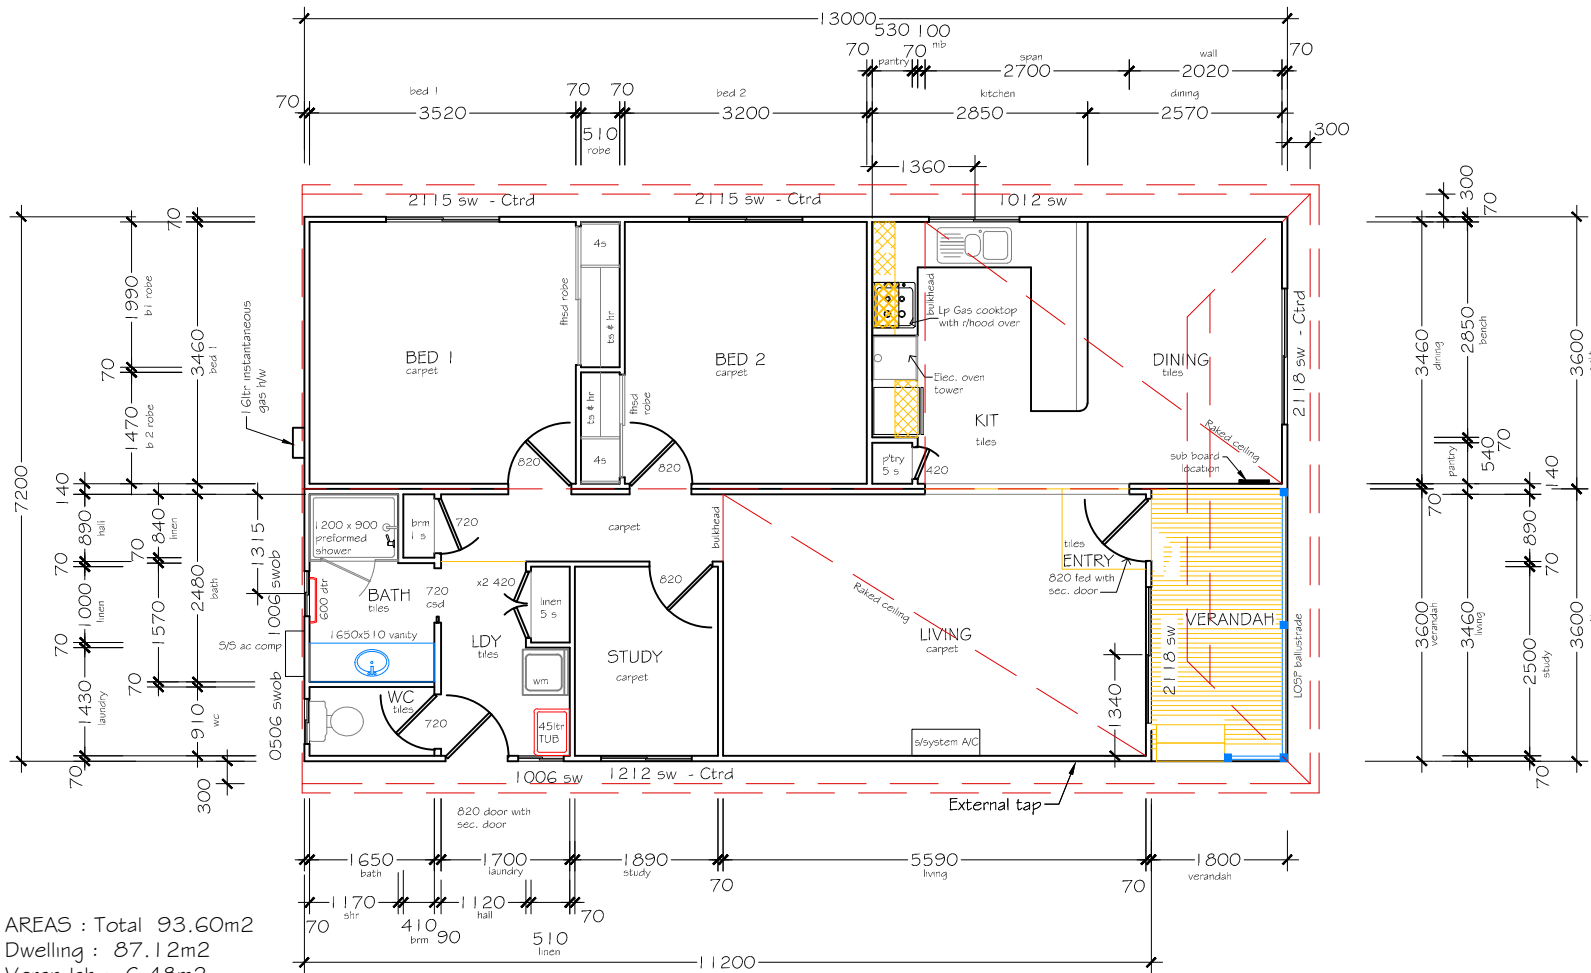

Sheet 2 of 7

Floor Plan

© Todd Devine Homes
All Rights Reserved



CAD REF Library/Acad/Std Designs/GN

CLIENT

**GOLD NUGGET
TOURIST PARK**

Approved by Client



TODD DEVINE HOMES
816 Mountain Highway, Bayswater Vic 3153
tel: (03) 9720 1686 fax: (03) 9720 1690
RBP DB U 9292

TDH

DRAWN

TDH

DESIGNED

TDH

CHECKED

TDH

CHECKED

DATE

04.08.10

1 : 100
SCALE

THE BYRON

GOLD NUGGET TOURIST PARK - EPSOM

CONTACT LINDA: 5448 4747

FLOOR PLAN












 




DRAWING NO.


GN STD- 02

REVISION 0



LEGEND:

-  Fdl Fluorescent Down Light
-  obl Opal Ball Light
-  32wfl 32W Round Fluro
-  flh Fan - Light - heater
-  ewb External Wall Bracket
-  SA Smoke Alarm
-  DP Double Power Point
-  SP Single Power Point
-  edpp External double power point
-  CFL Ceiling Fan/light
-  cfl
-  TV TV Outlet
-  tel Telephone
-  ef Exhaust fan
-  CF Ceiling Fan
-  CF only

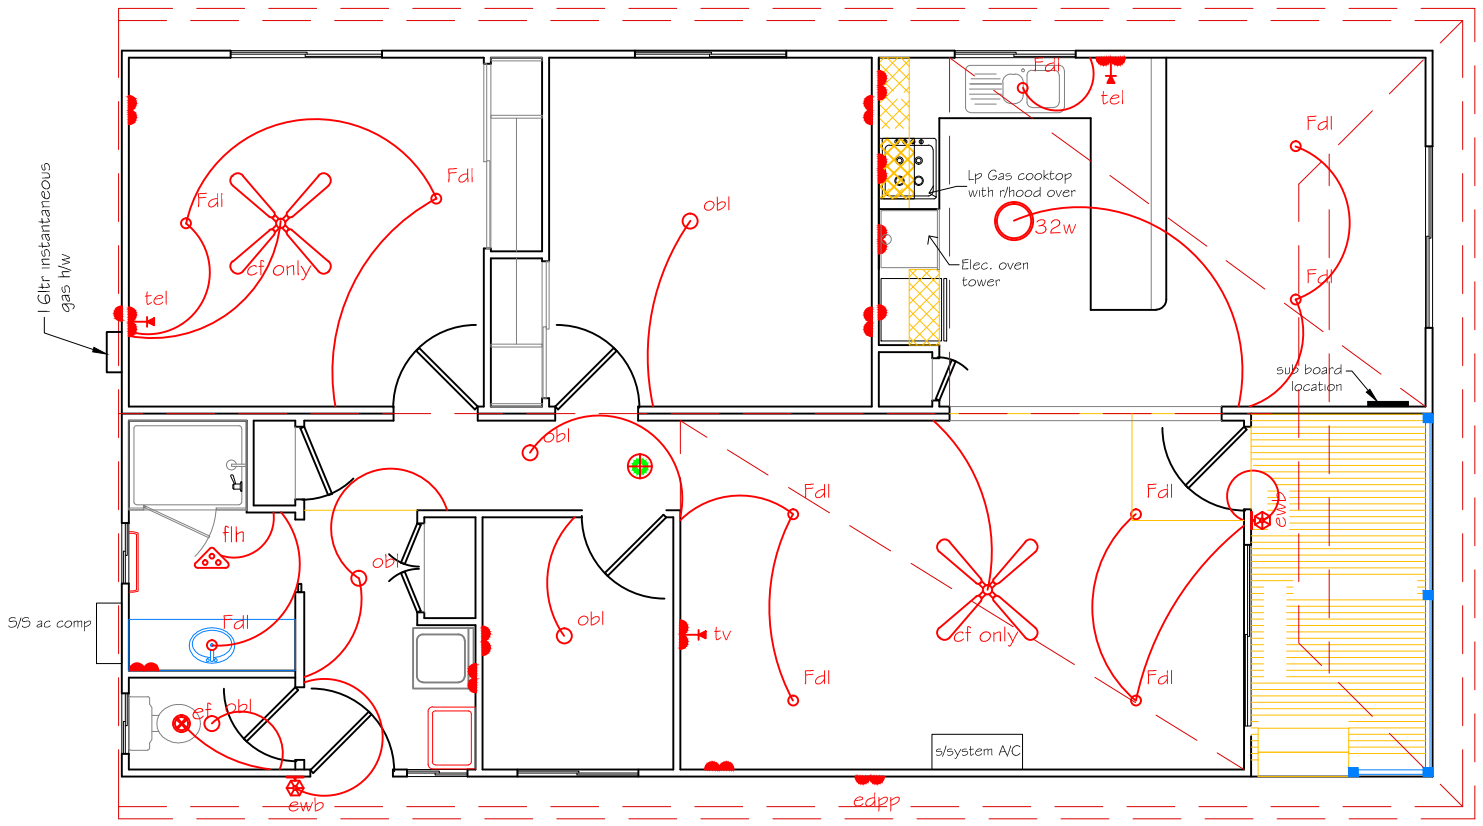


Todd Devine Homes

Builders of quality dependent relatives units,
transportable homes and tourist accommodation.

CAD REF Library/Acad/Std Designs/GN

 CLIENT
**GOLD NUGGET
TOURIST PARK**
Approved by Client



TODD DEVINE HOMES
816 Mountain Highway, Bayswater Vic 3153
tel: (03) 9720 1686 fax: (03) 9720 1690
RBP DB U 9292

DRAWN	TDH	TDH
	CHECKED	CHECKED
DESIGNED	TDH	04.08.10
	DATE	DATE
1 : 75 SCALE		

THE BYRON


GOLD NUGGET TOURIST PARK - EPSOM
CONTACT LINDA: 5448 4747
ELECTRICAL PLAN

DRAWING NO.
GN STD- 03


REVISION **0**

Todd Devine Homes


Builders of quality dependent relatives units,
transportable homes and tourist accommodation.

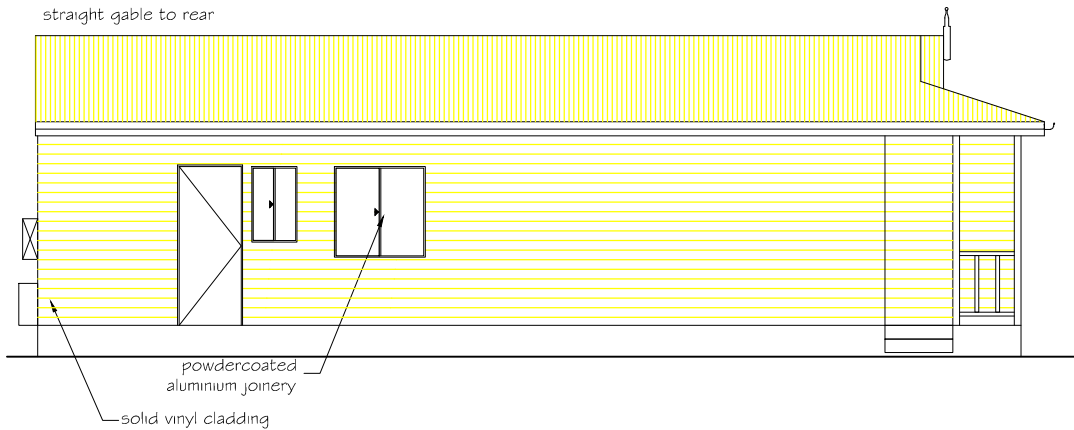


ELEVATION A

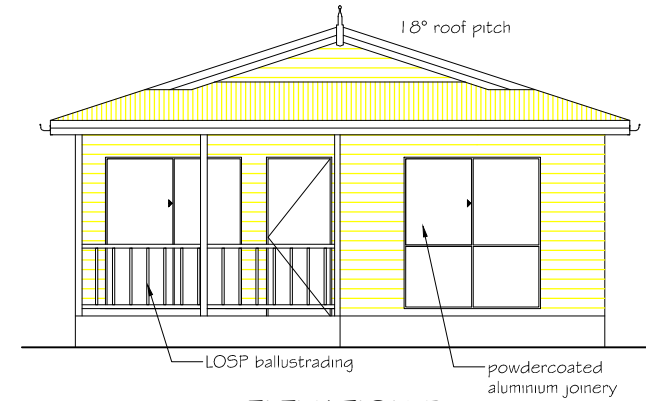


ELEVATION B

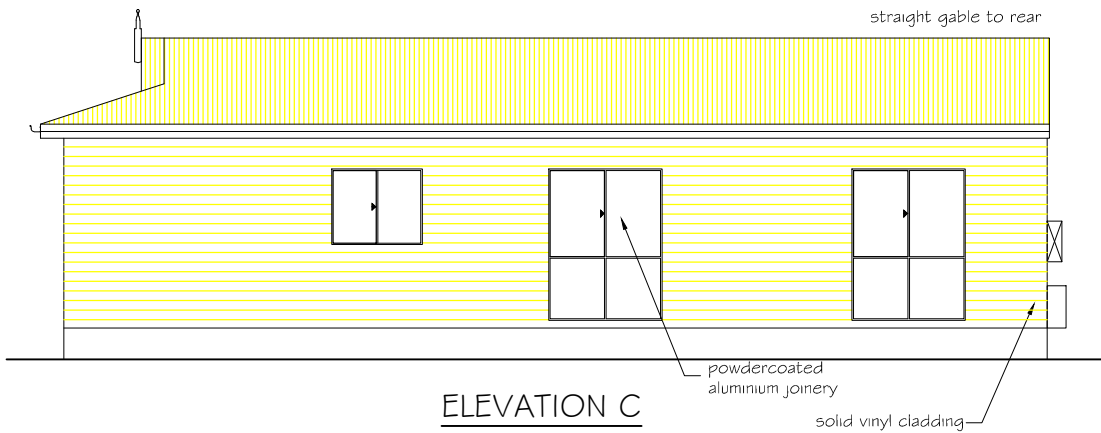

ELEVATION C

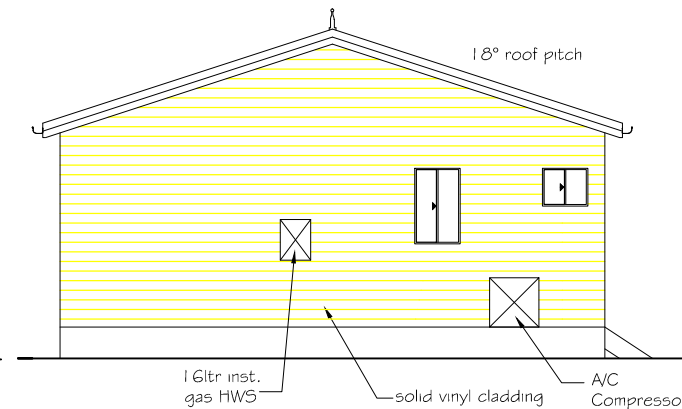

ELEVATION D

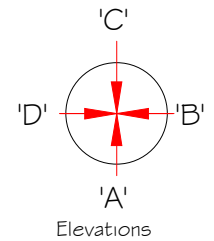

Sheet 4 of 7

Elevations

© Todd Devine Homes
All Rights Reserved



CAD REF Library/Acad/Std Designs/GN

CLIENT
**GOLD NUGGET
TOURIST PARK**
Approved by Client



TODD DEVINE HOMES
816 Mountain Highway, Bayswater Vic 3153
tel: (03) 9720 1686 fax: (03) 9720 1690
RBP DB U 9292

DRAWN	TDH	TDH CHECKED
	TDH	TDH CHECKED
DESIGNED		04.08.10 DATE
1 : 100 SCALE		

THE BYRON
GOLD NUGGET TOURIST PARK - EPSOM
CONTACT LINDA: 5448 4747
ELEVATIONS

DRAWING NO.
GN STD- 04

REVISION
0